


1-FOR GENERAL NOTES AND SYMBOLS REFER TO DWG. NO. 1205-00-HV-SDG-785,
2-THE DIMENSIONS OF ALL EQUIPMENT ARE ESTIMATED VALUES. THE EXACT VALUE
WILL BE SPECIFIED ACCORDING VENDOR DATA.
4-THE APPROXIMATE HEIGHT OF PAHU-0030 A/B IS:1.7m
A/C-0030 A/B IS:1.3m
5-FOR EXACT LOCATION OF OPENINGS REFER TO CIVIL DWGS.
6-HOLD FOR REFRIGERANT PIPING PLAN.
EQUIPMENT CONNECTION DUCTING AND PIPING WILL BE ADDED TO THIS DWG AFTER
RECEIVING VENDOR DATA.

REFERENCE DRAWING	DWG. NO.
G.A. PLAN FOR GROUND & FIRST FLOOR	1203-00-ST-DWG-947
SUB. BUL. ROOF SLOPING PLAN & DET.	1205-00-HV-DWG-950
SUBSTATION DUCTING LAYOUT	1205-00-HV-DWG-021

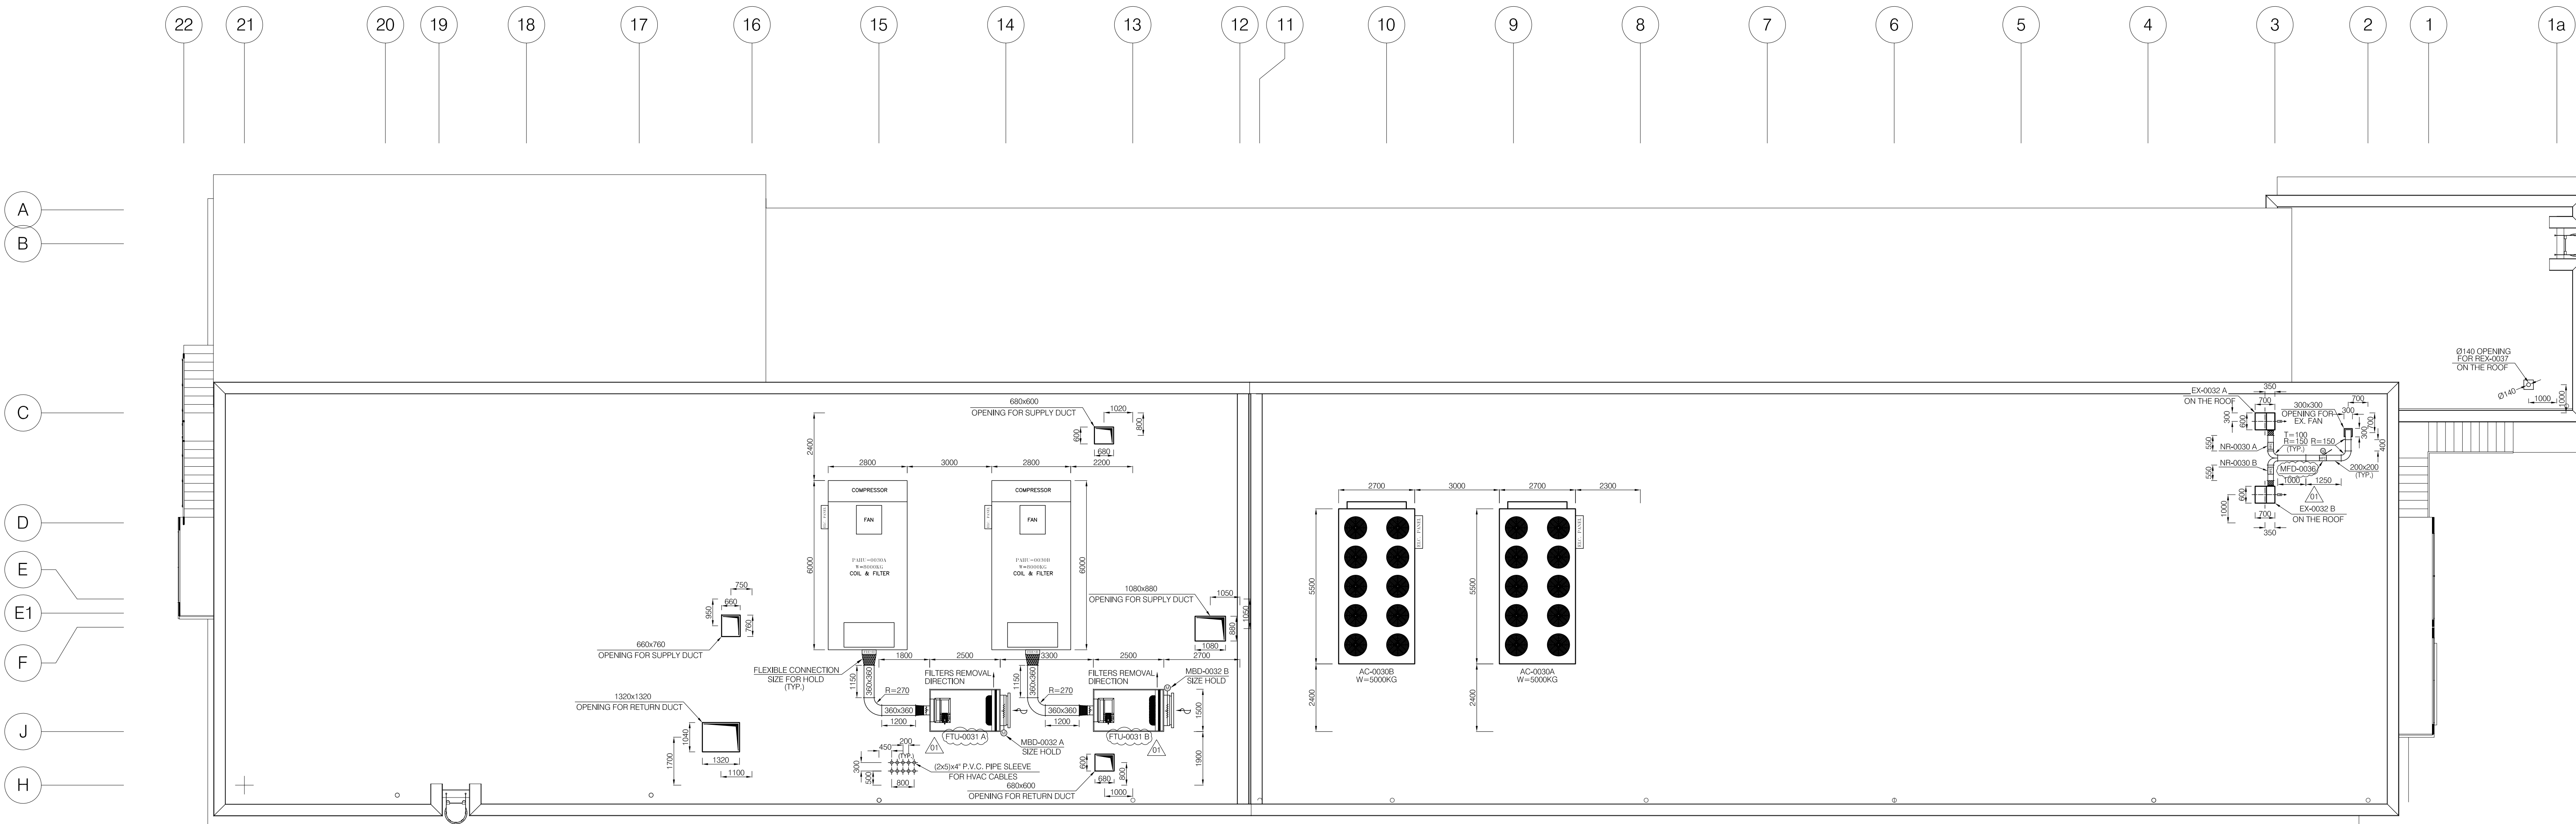

SC. 1:100

**APPROVED
FOR CONSTRUCTION**
DENA METHANOL PLANT / 1205

ED		EXT	AFC			A
Eng. Phase		Purpose of Distribution (POD)	Purpose of Issue (POI)			Owners Action
01	20.05.2017	APPROVED FOR CONSTRUCTION	M.M	A.M	A.M	N.J.
00	13.10.2016	ISSUED FOR ENGINEERING	M.M	A.M	A.M	N.J.
REV.	ISSUE DATE	DESCRIPTION	Prepared by	Checked by	Approved by	Project

THIS DOCUMENT IS THE PROPERTY OF SPEC. IT IS CONTAINED HEREIN FOR THE USE OF THE CLIENT ONLY. THIS DRAWING IS NOT TO BE REPRODUCED, COPIED OR IN ANY MANNER, WITHOUT THE PRIOR WRITTEN PERMISSION OF THE PROJECT ENGINEER.	 DENA METHANOL PLANT OWNER: SABALAN PETROCHEMICAL INDUSTRIES CO. شرکت صنایع پتروشیمی سیلان No. 1, Of 1	
	 PETROCHEMICAL INDUSTRIES DESIGN & ENGINEERING COMPANY شرکت طراحی و مهندسی صنایع پتروشیمی TITLE: SUBSTATION - MECHANICAL ROOM EQUIPMENT ARRANGEMENT AND REFRIGERANT PIPING PLAN	
	SCALE: 1/100	OWNER PROJECT NO.: 893-0120 DWG. NO.: 1205-00-HV-DWG-025
	SHEET NO. OF 1	PROJECT PROJECT NO.: 1205

THIS DOCUMENT IS THE PROPERTY OF SPIC. IT IS CONFIDENTIAL AND ALL RIGHTS ARE RESERVED. NEITHER THE WHOLE NOR PART OF THIS DOCUMENT MAY BE DISCLOSED TO ANY THIRD PARTY, REPRODUCED, STORED IN ANY RETRIEVAL SYSTEM OR TRANSMITTED IN ANY FORM OR BY ANY MEANS WITHOUT THE PRIOR WRITTEN CONSENT OF SPIC.